



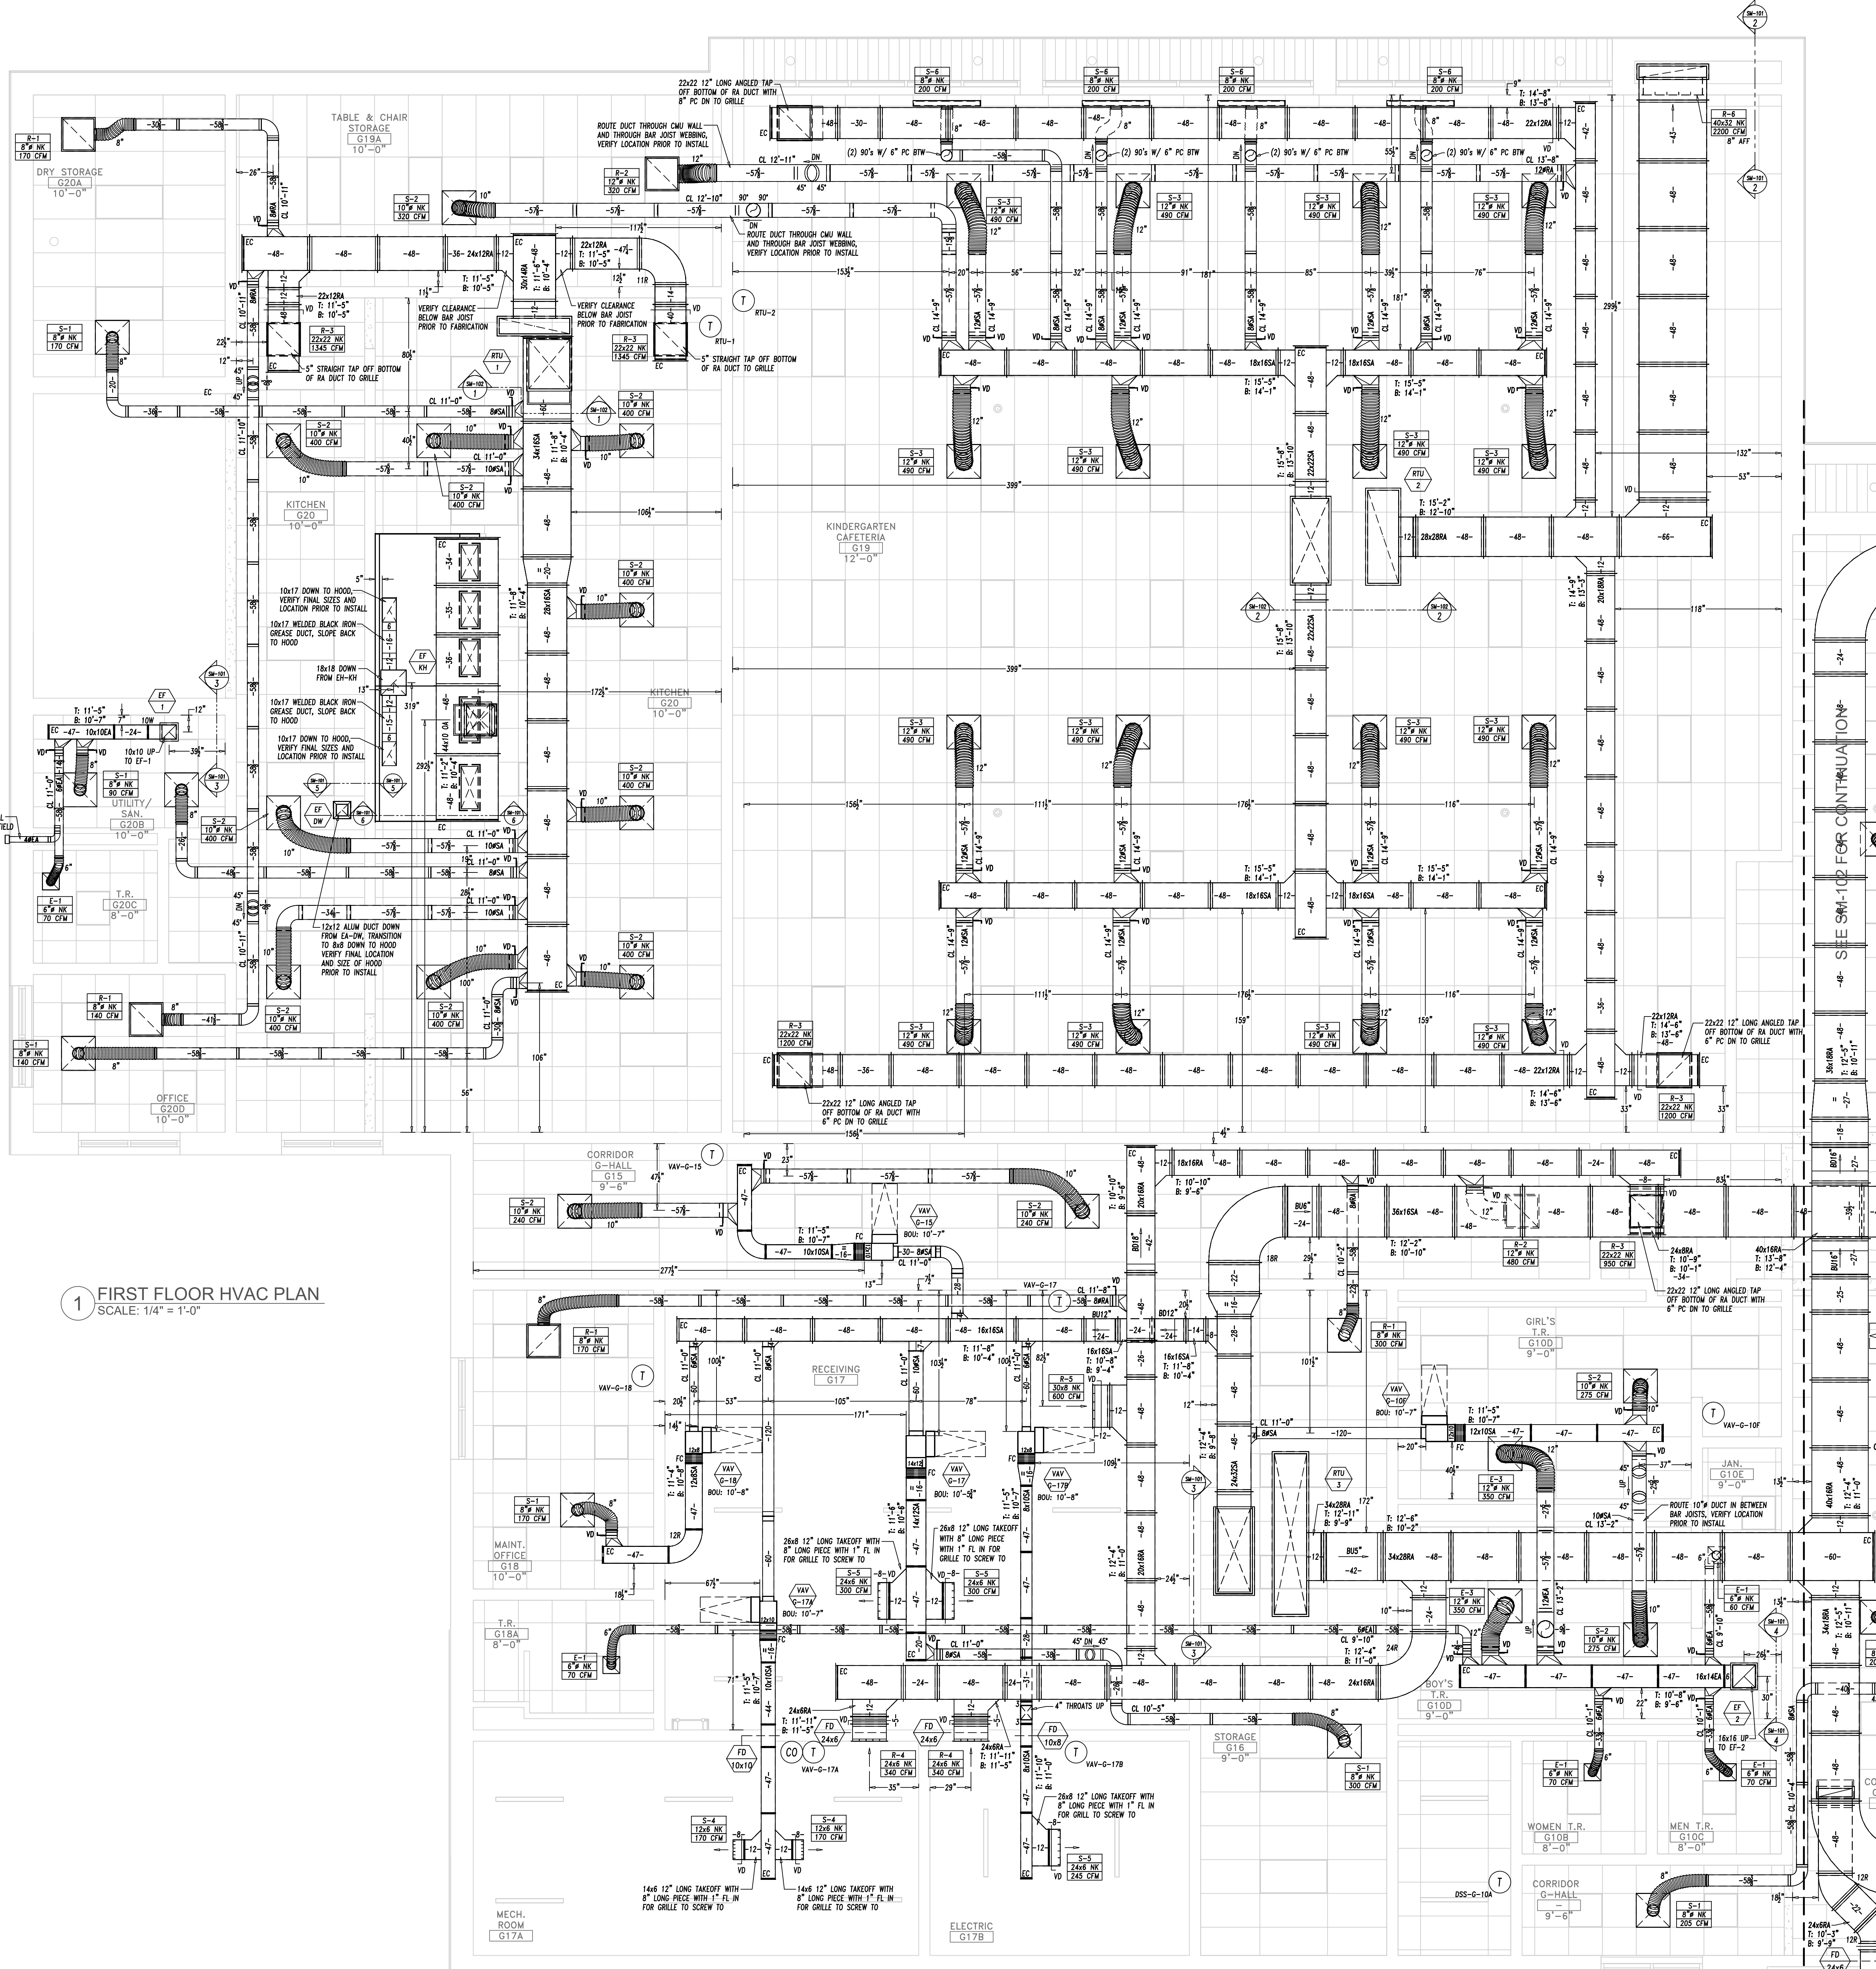


1 FIRST FLOOR HVAC PLAN
SCALE: 1/4" = 1'-0"

2 RA DUCT SECTION VIEW
SCALE: 1/4" = 1'-0"

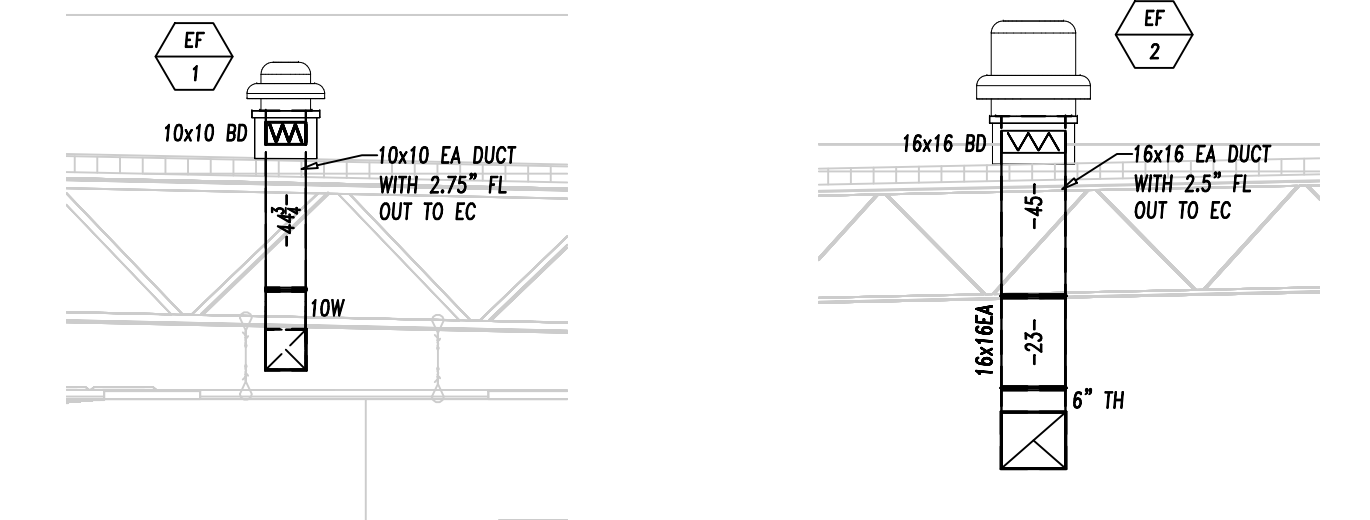


3 EF-1 SECTION VIEW
SCALE: 1/4" = 1'-0"

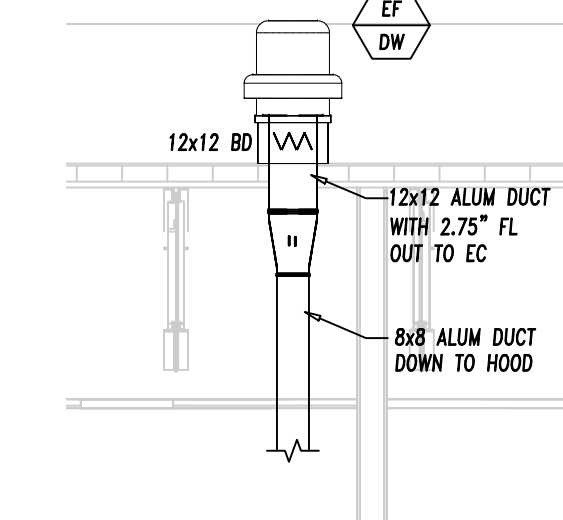

4 EF-2 SECTION VIEW
SCALE: 1/4" = 1'-0"




5 EF-DW SECTION VIEW
SCALE: 1/4" = 1'-0"

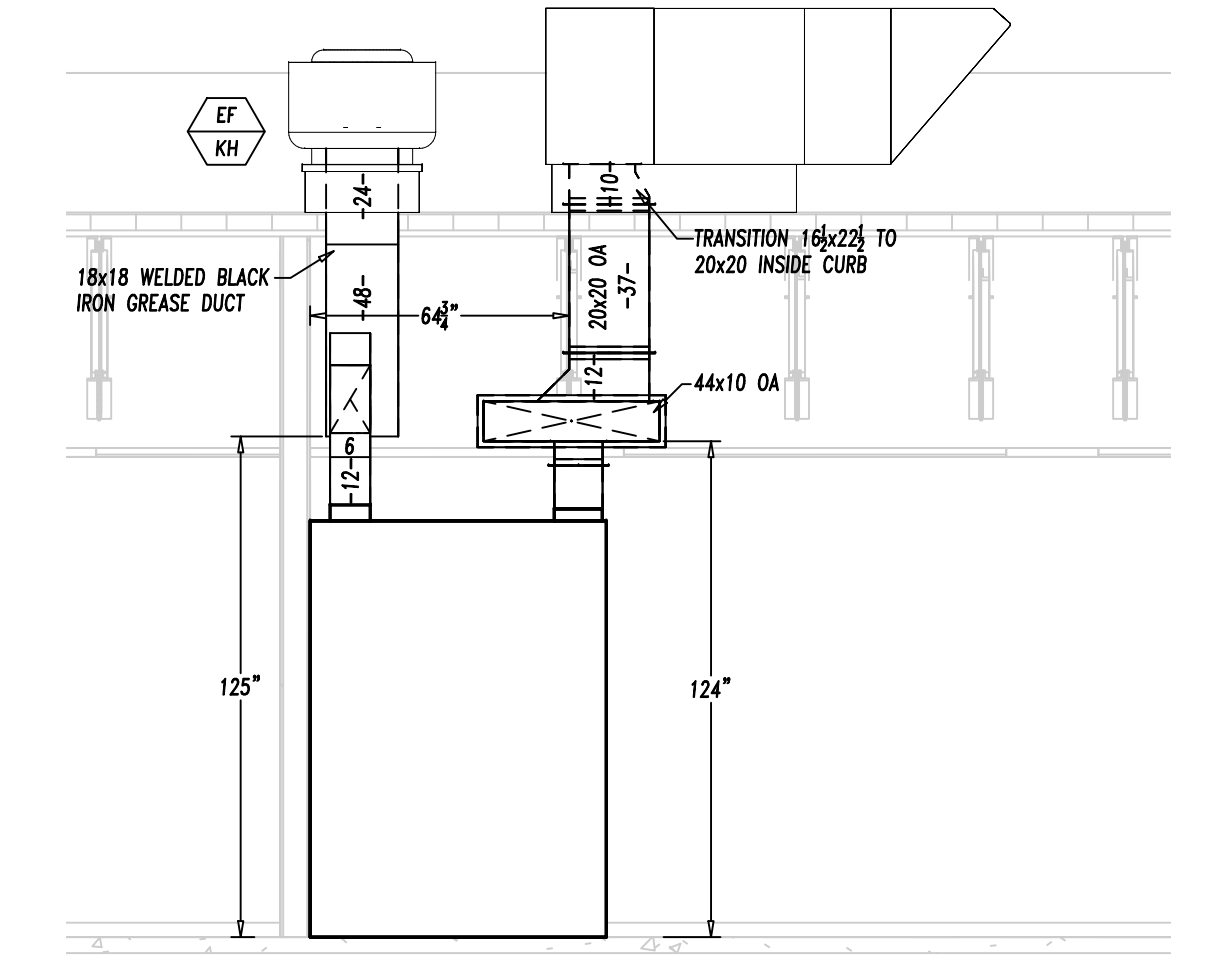

6 EF-KH & MAU-1 SECTION VIEW
SCALE: 1/4" = 1'-0"

REV:	DESCRIPTION:	BY:	DATE:
-	-	-	-
-	-	-	-
-	-	-	-
CONSTRUCTION ISSUE			






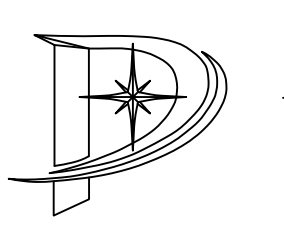


Polaris Drafting LLC
PO Box 1033
Arlington, PA 19001
Phone: 215-326-9404

CLIENT:			
SITE:			
TITLE: HVAC NEW WORK First Floor			
SCALE: AS SHOWN	DATE:	DRAWN: SS	CHECKED: SS
PROJECT NO: -	DRAWING NO: SM-101	REVISION: -	




Scott C. Shea
1A1381896

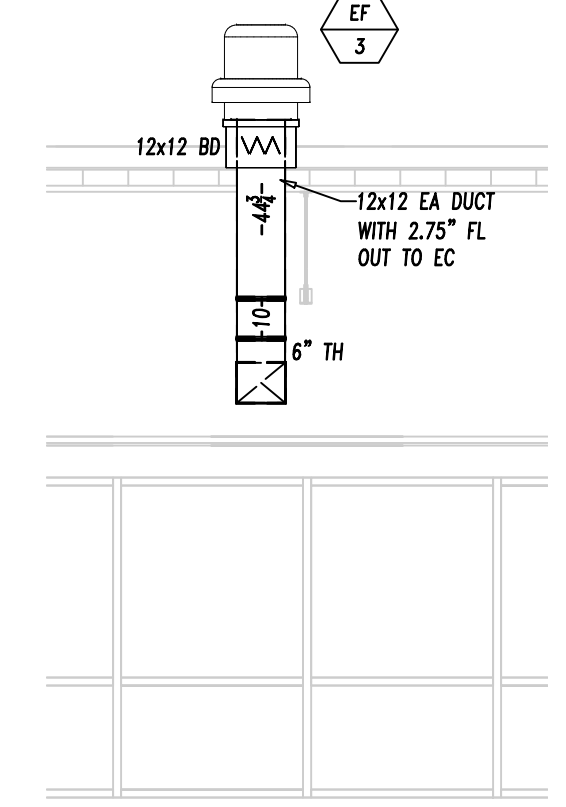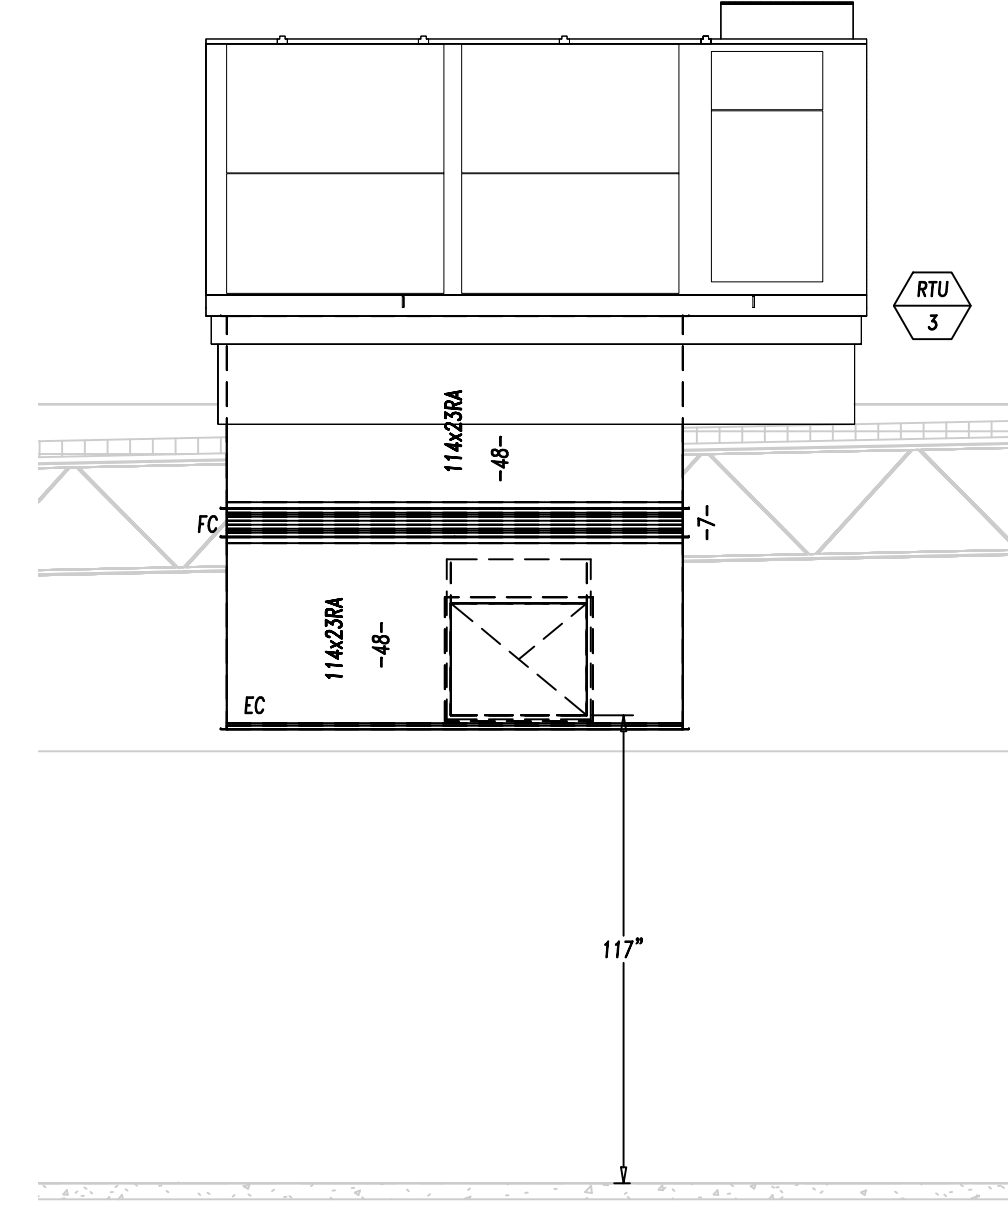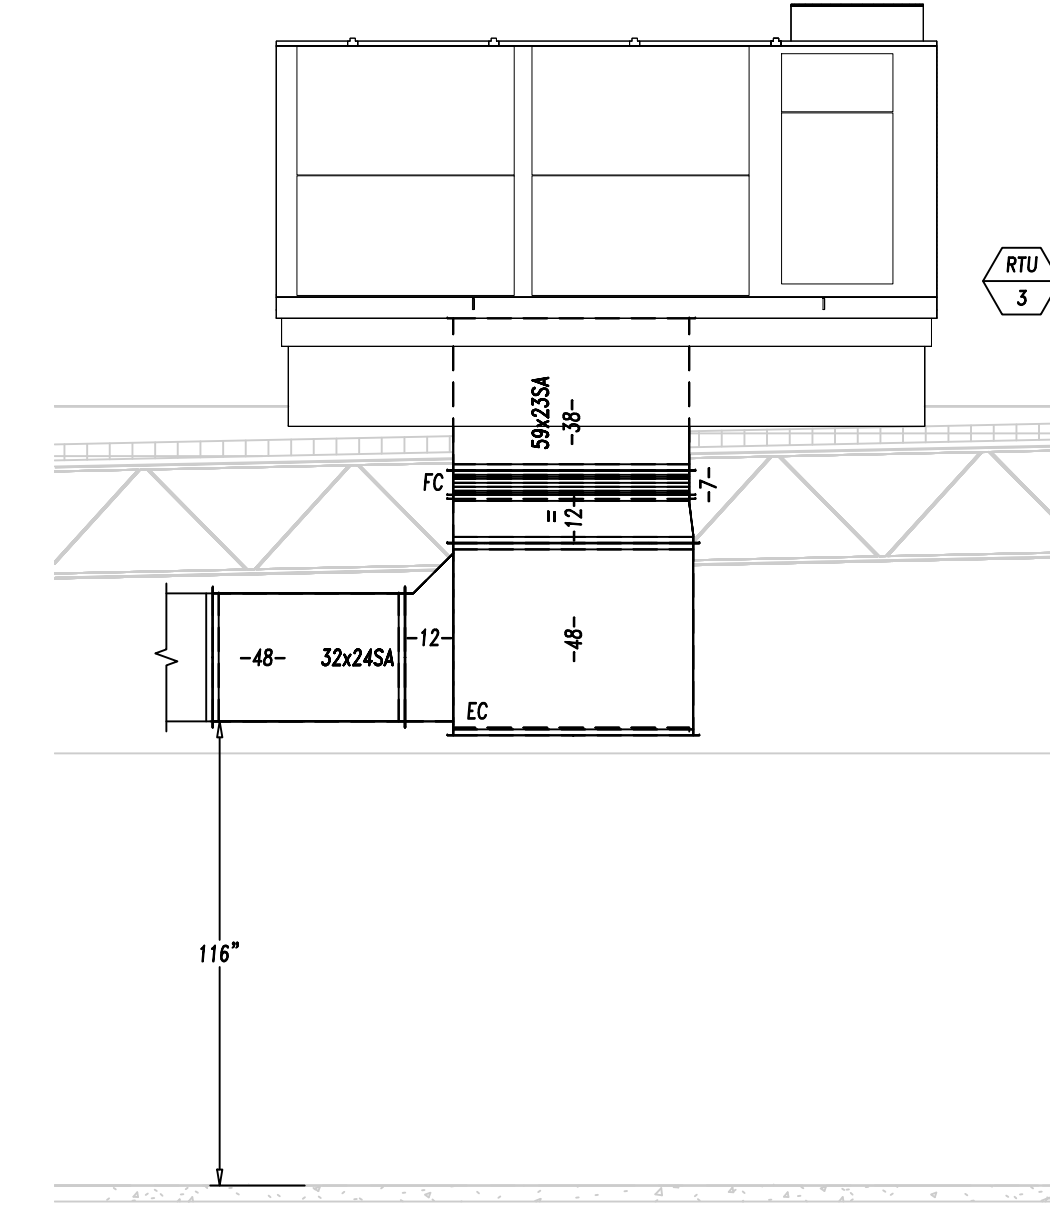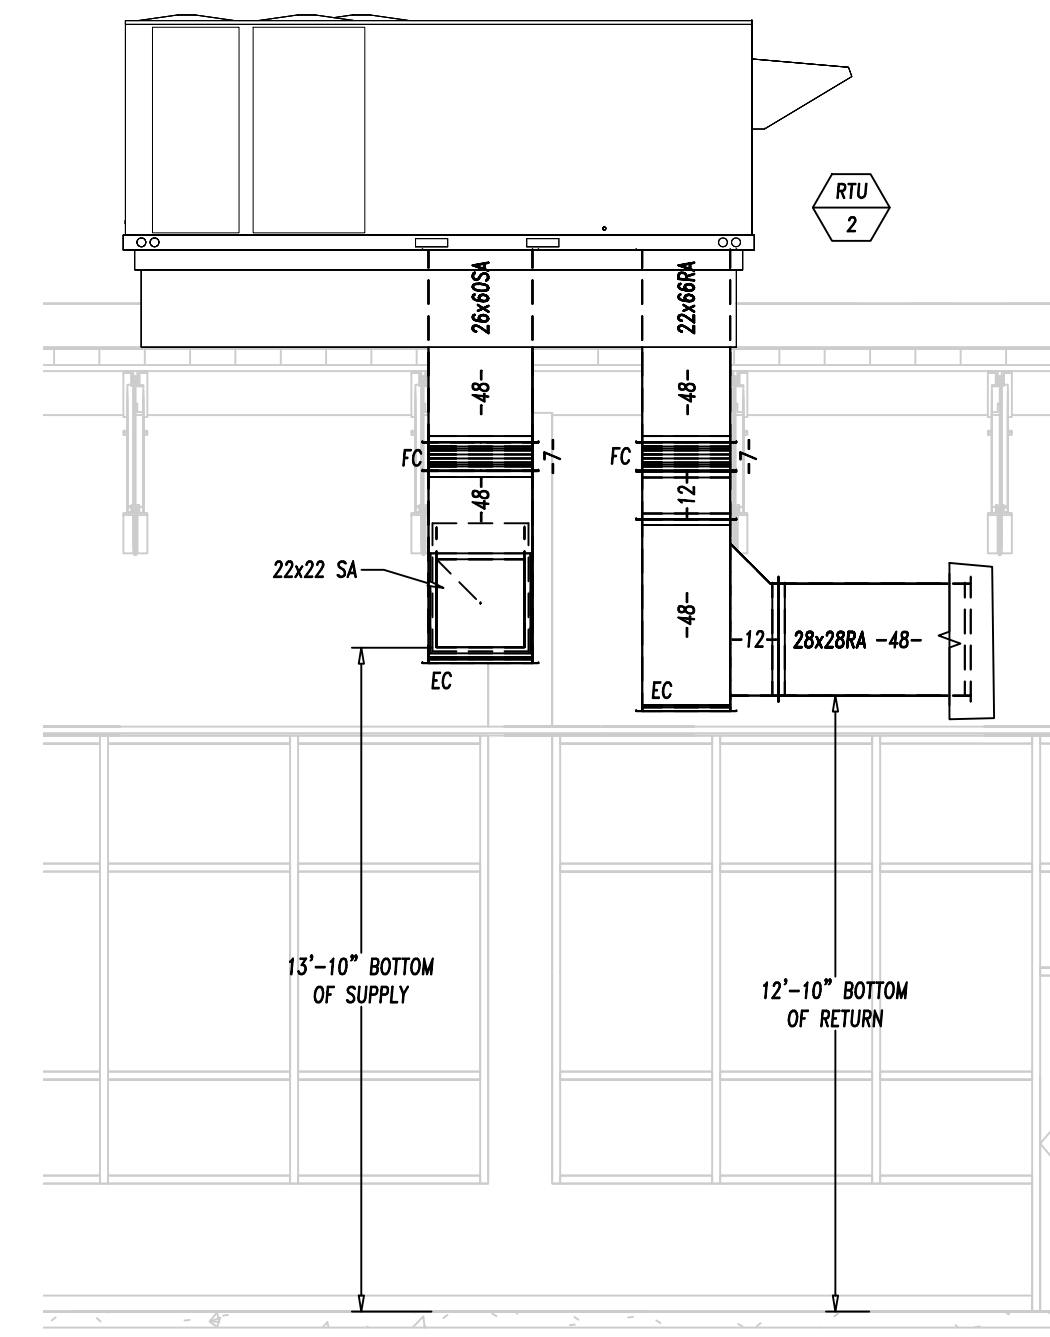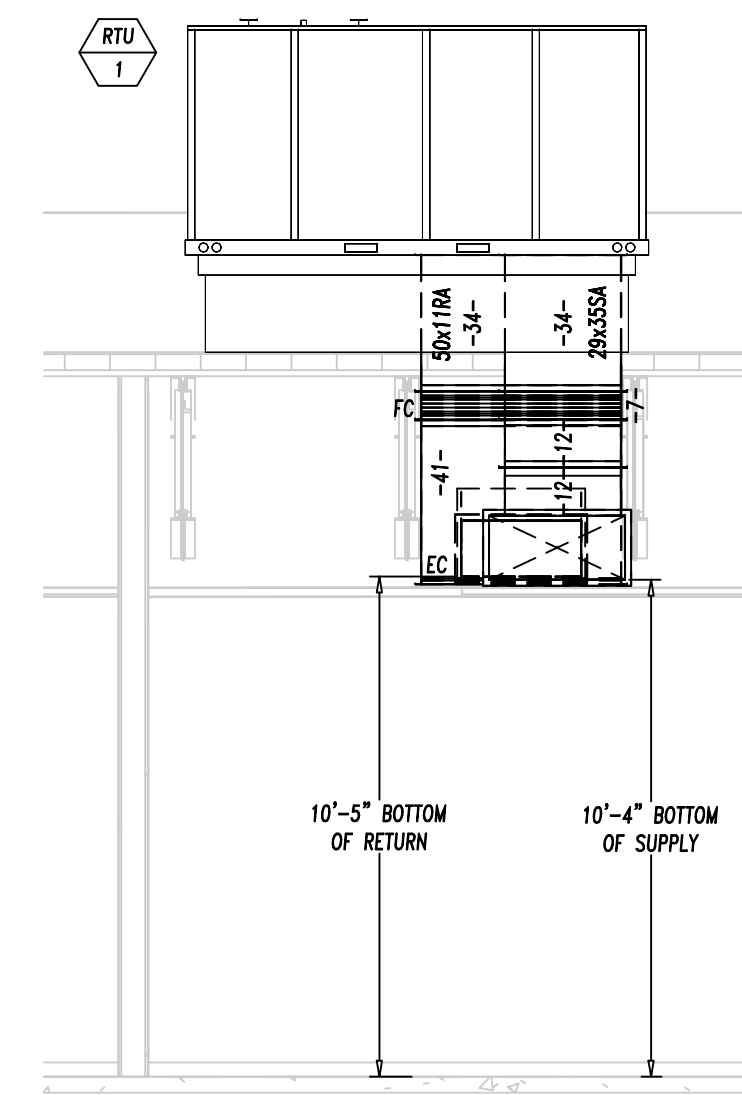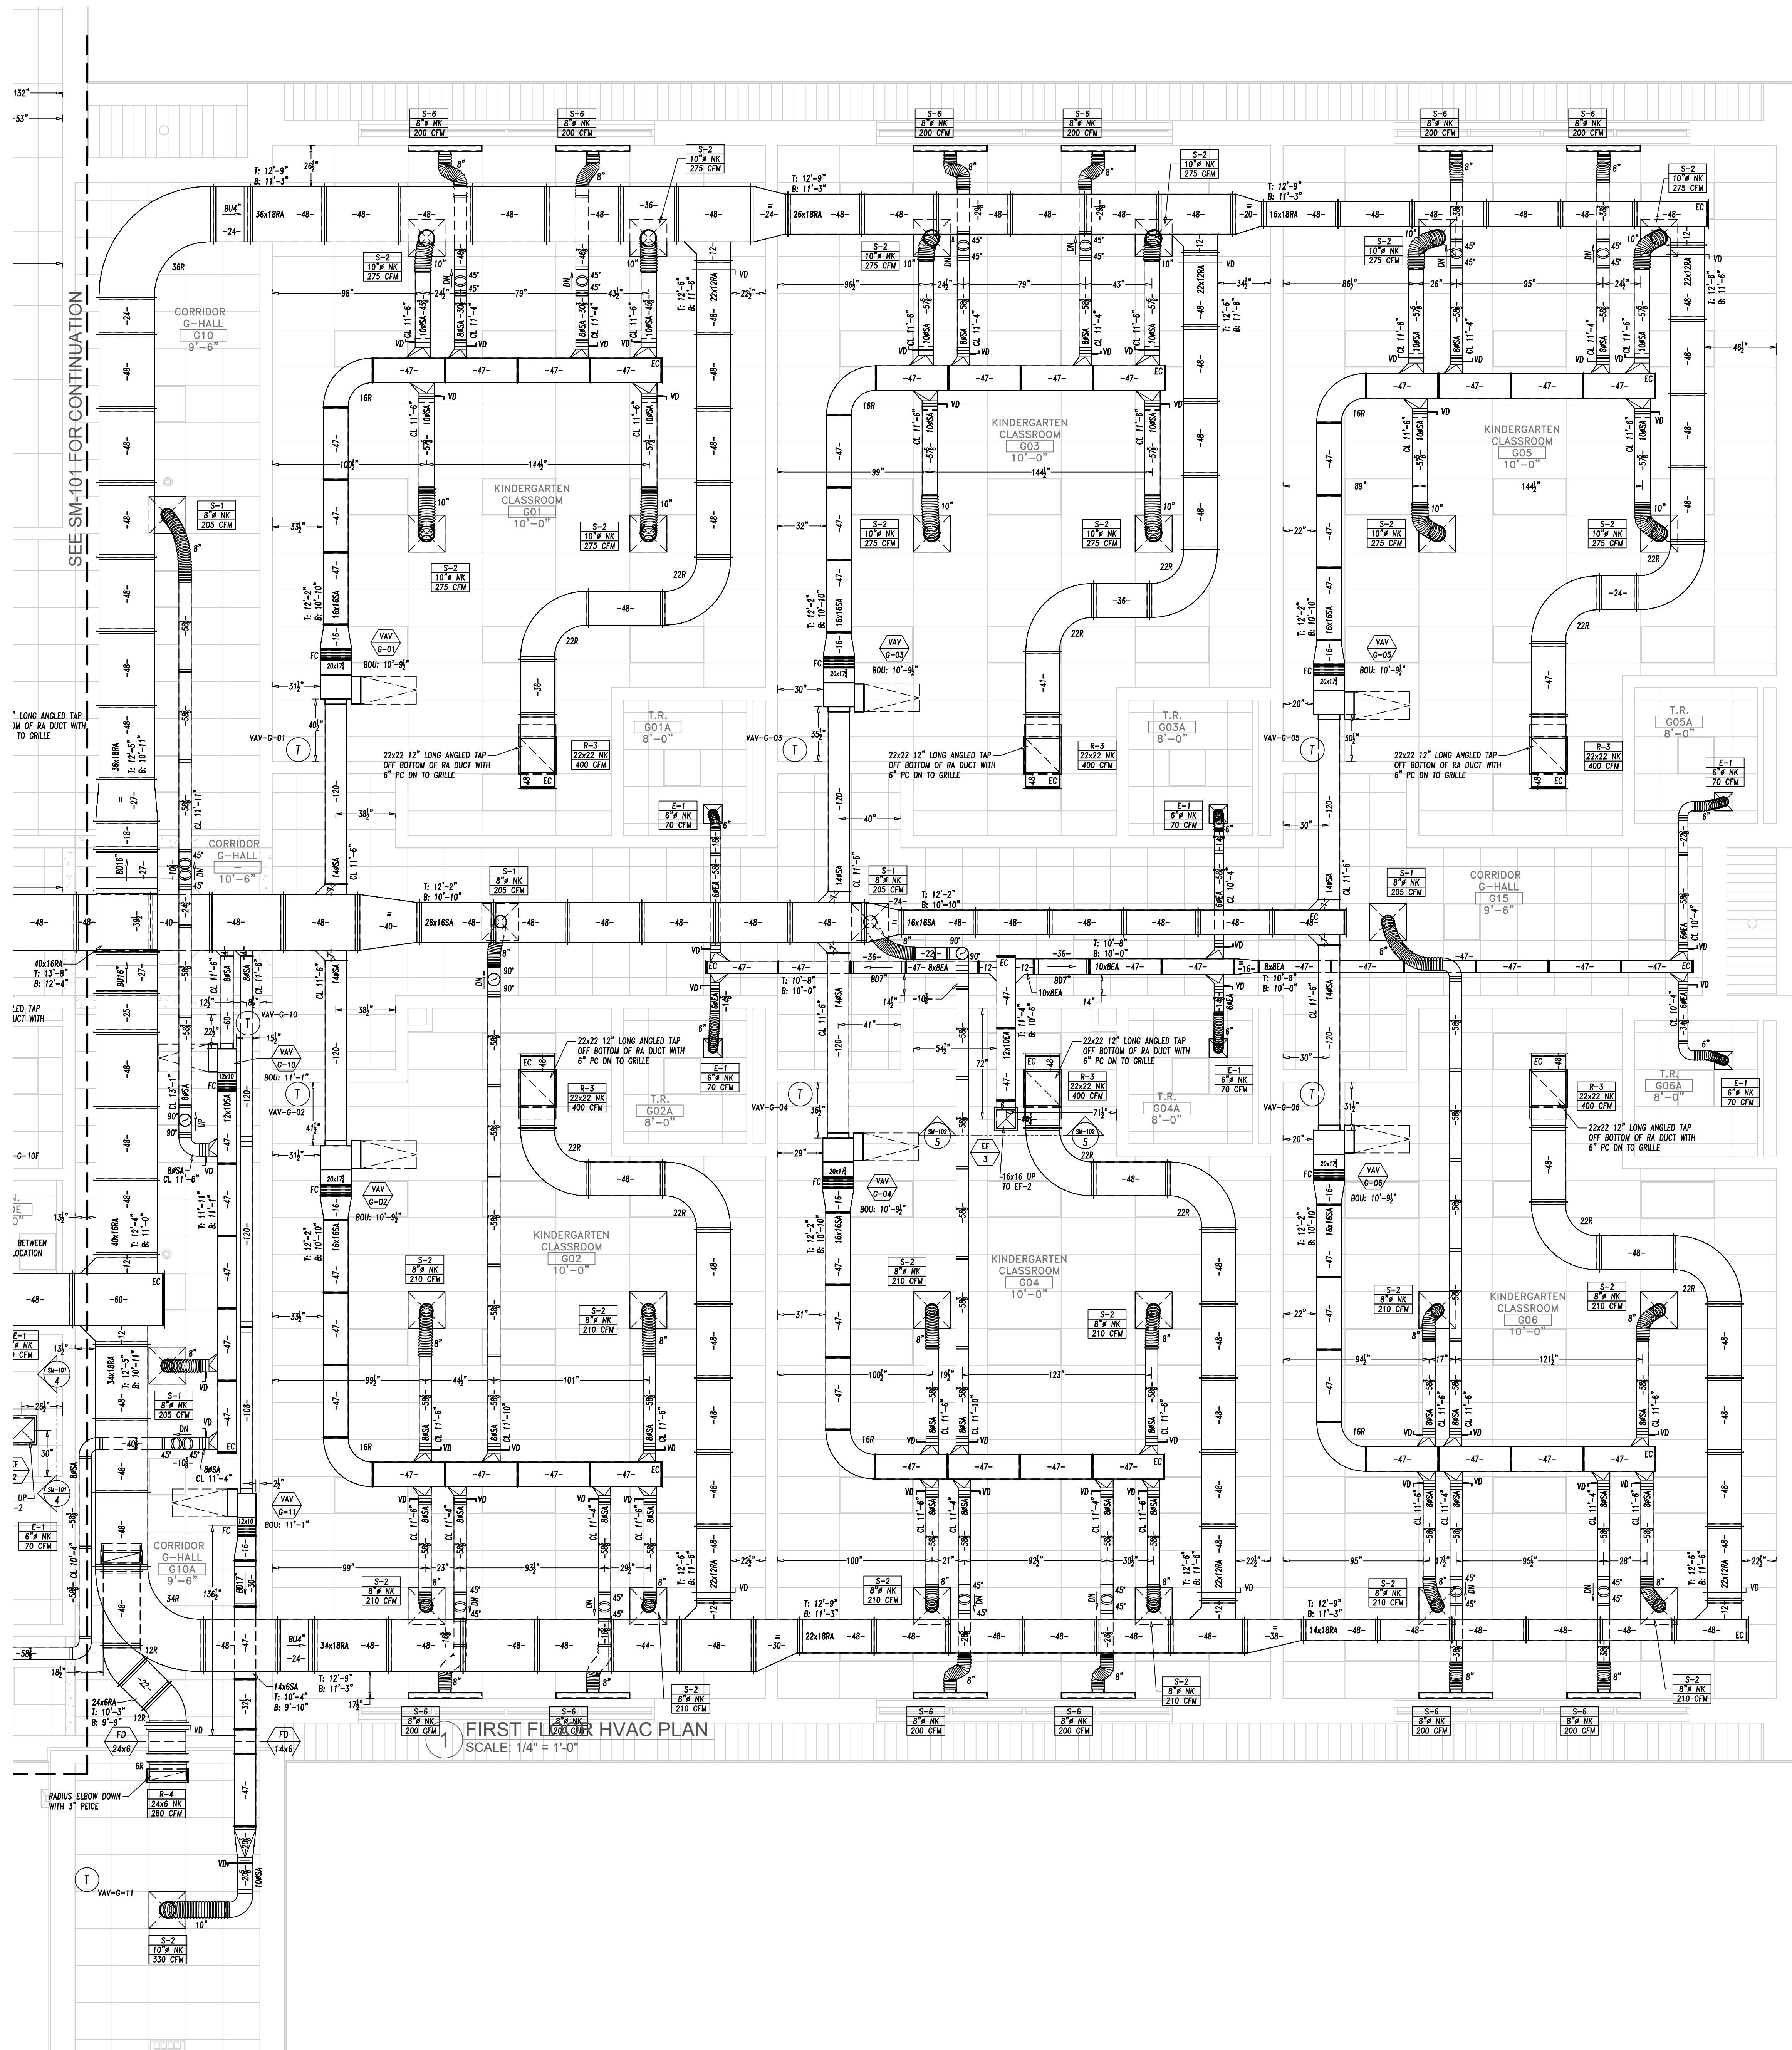

-	-	-	-
-	-	-	-
-	-	-	-
-	-	1	-

REV:	DESCRIPTION:	BY:	DATE:
STATUS: CONSTRUCTION ISSUE			

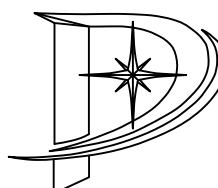

Polaris Drafting LLC
PO Box 1033
Abington, PA 19001
Phone: 215-326-9404

CLIENT:			
SITE:			


TITLE:			
HVAC NEW WORK First Floor			

SCALE: AT: 1/4" = 1'-0"	DATE:	DRAWING: SS	CHECKED: SS
PROJECT NO:	DRAWING NO:	REVISION:	
-	SM-102	-	




Scott C. Shea
1A11381896

Polaris Drafting LLC
PO Box 1033
Abington, PA 19001
Phone: 215-326-9404

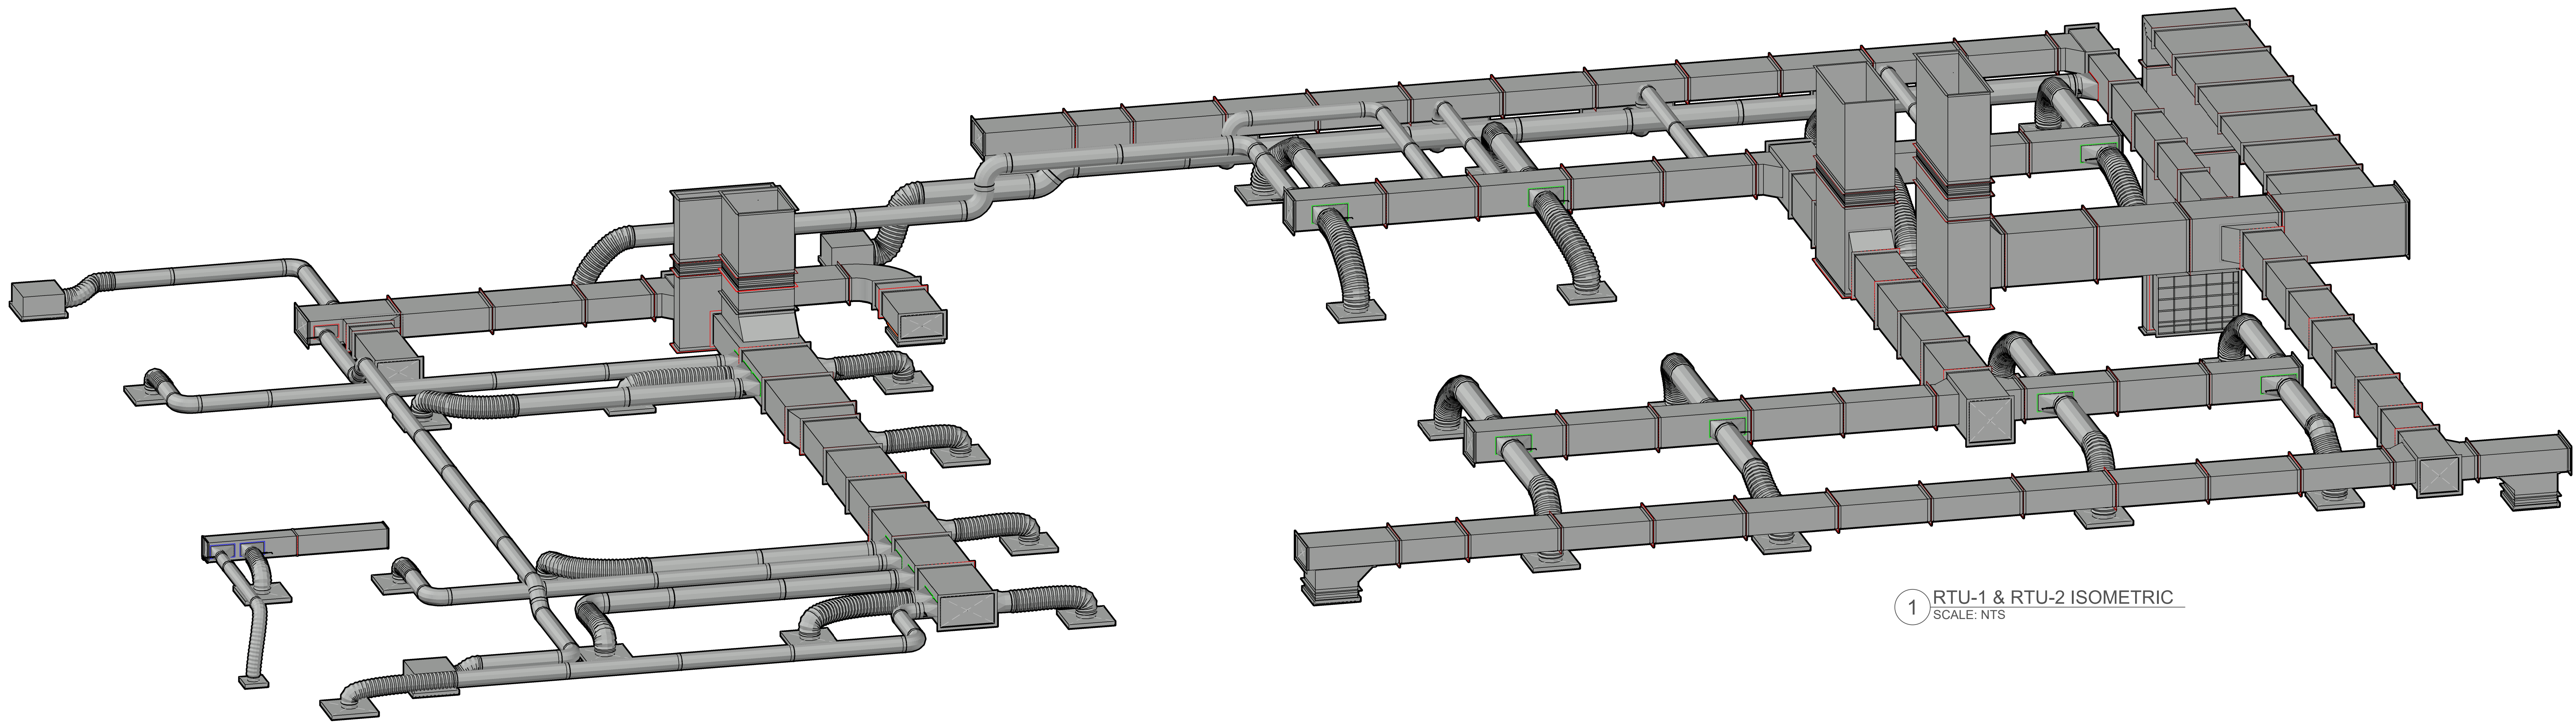


1 RTU-1 & RTU-2 ISOMETRIC
SCALE: NTS

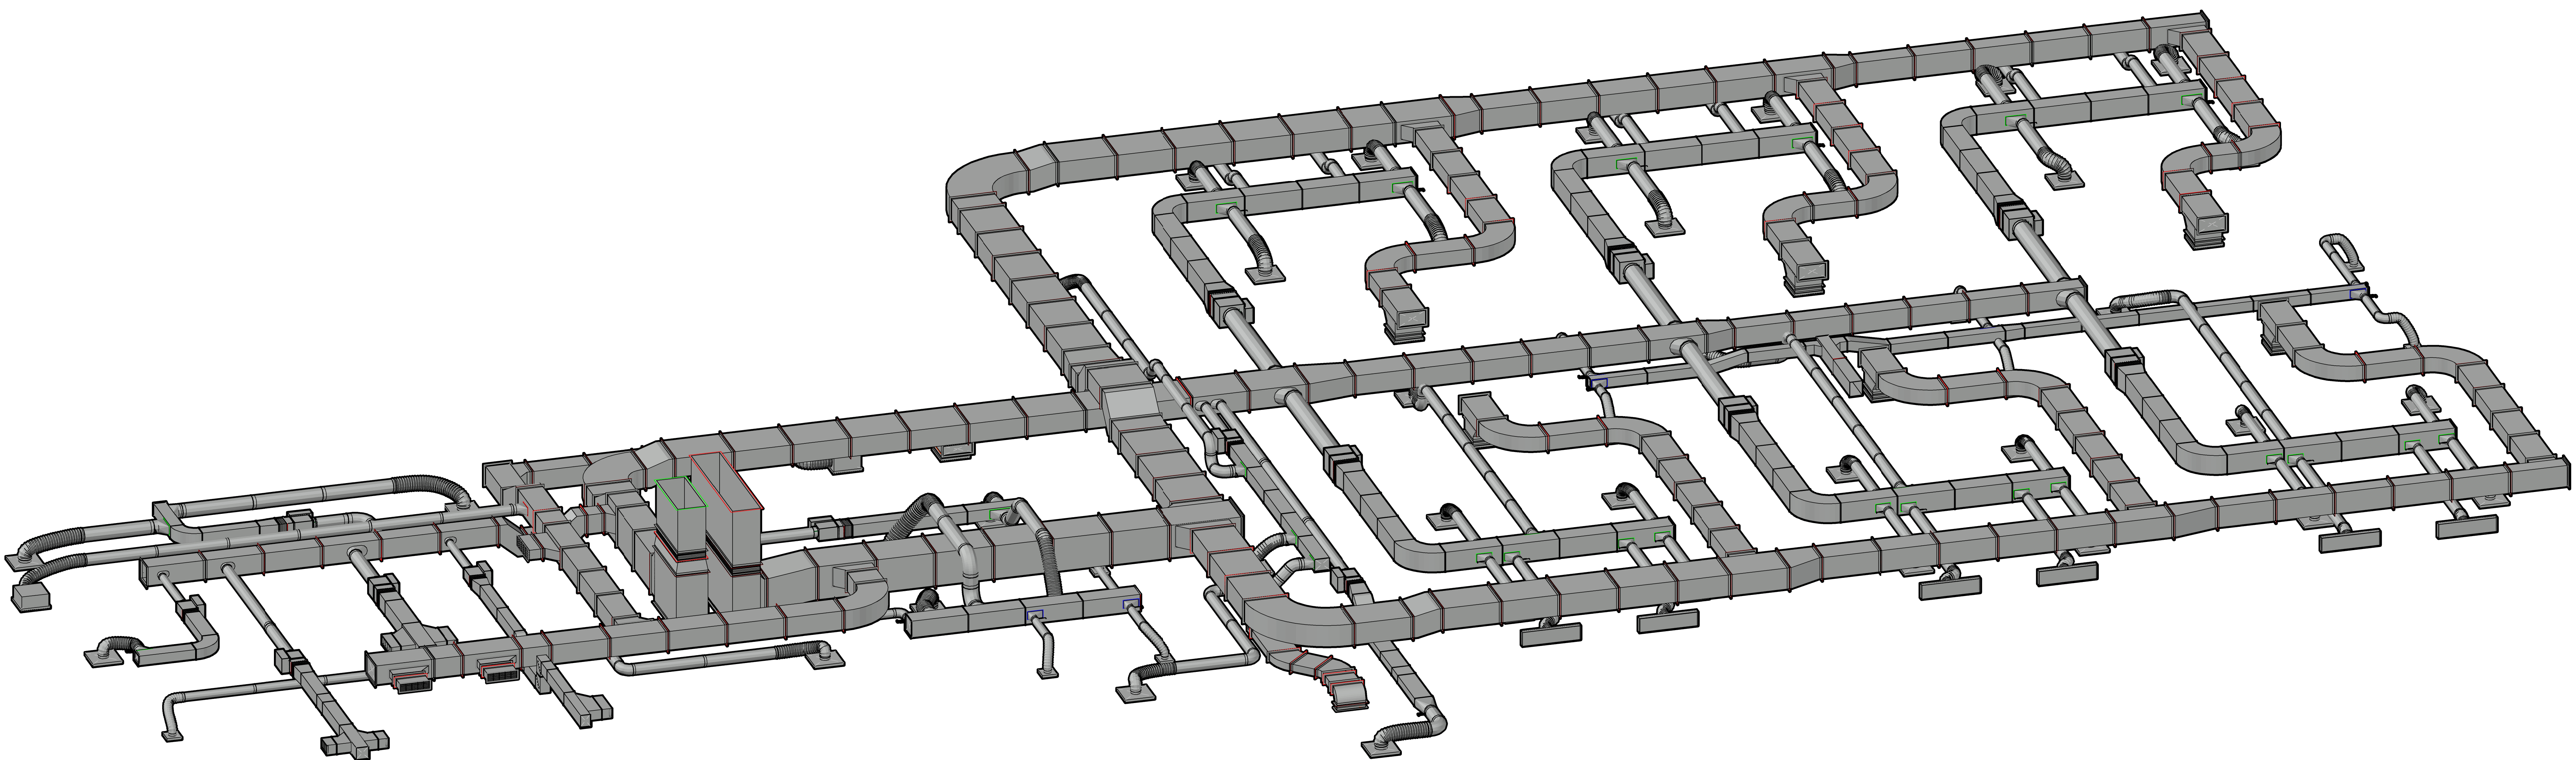

2 RTU-3 ISOMETRIC
SCALE: NTS



REV:	DESCRIPTION:	BY:	DATE:
-	-	-	-
-	-	-	-
-	-	1	-
STATUS: CONSTRUCTION ISSUE			

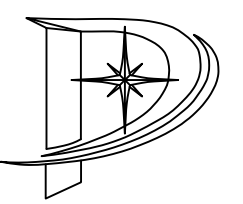 **Polaris Drafting LLC**
PO Box 1033
Abington, PA 19001
Phone: 215-326-9404

CLIENT:

SITE:

TITLE: HVAC NEW WORK First Floor			
SCALE: AT A1: AS SHOWN	DATE:	DRAWN: SS	CHECKED: SS
PROJECT NO: -	DRAWING NO: SM-102	REVISION: -	