



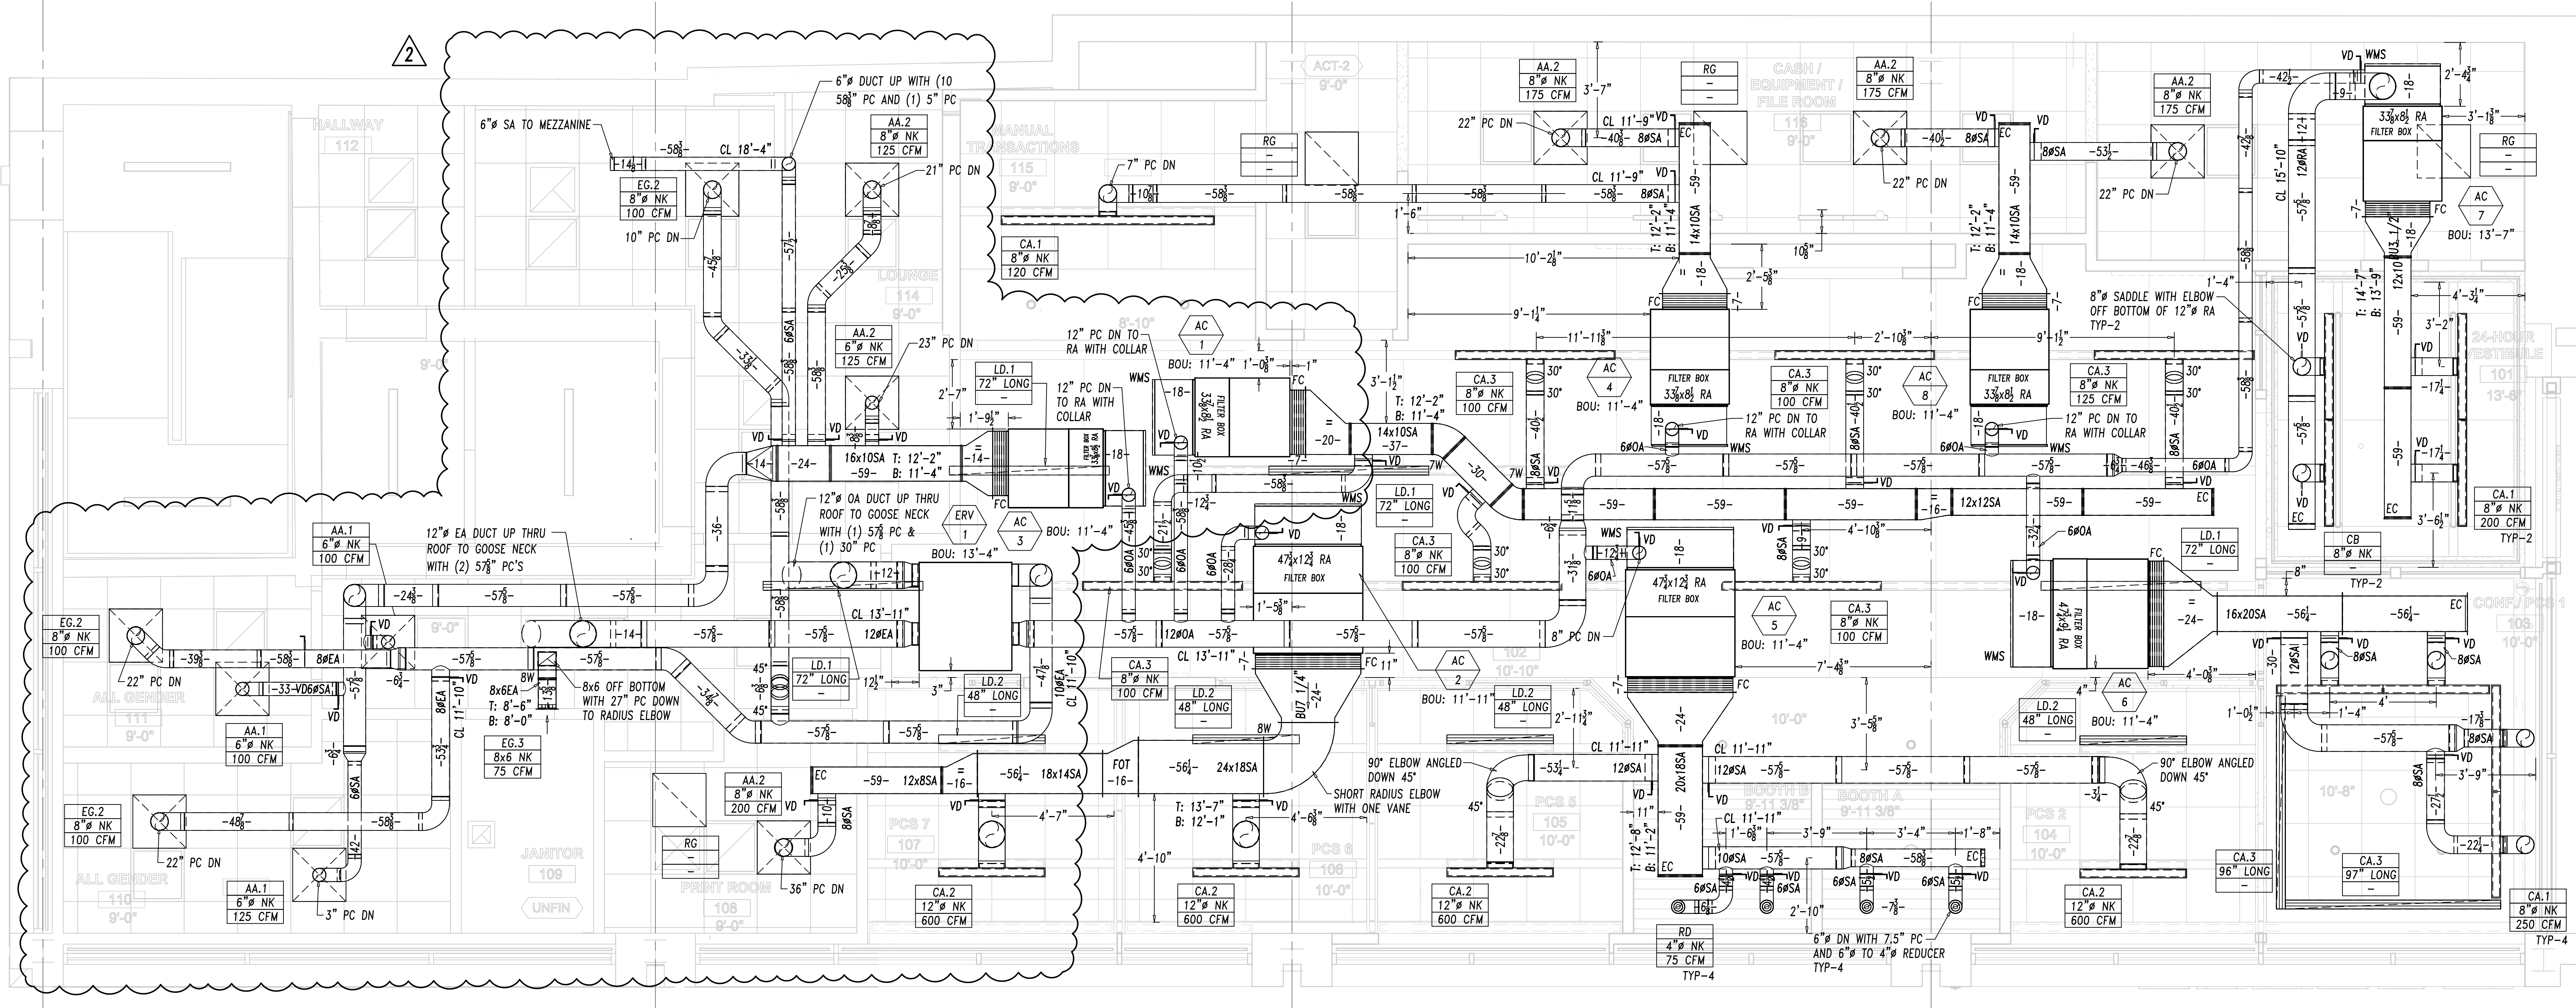

1 FIRST FLOOR HVAC PLAN
SCALE: 1/4" = 1'-0"

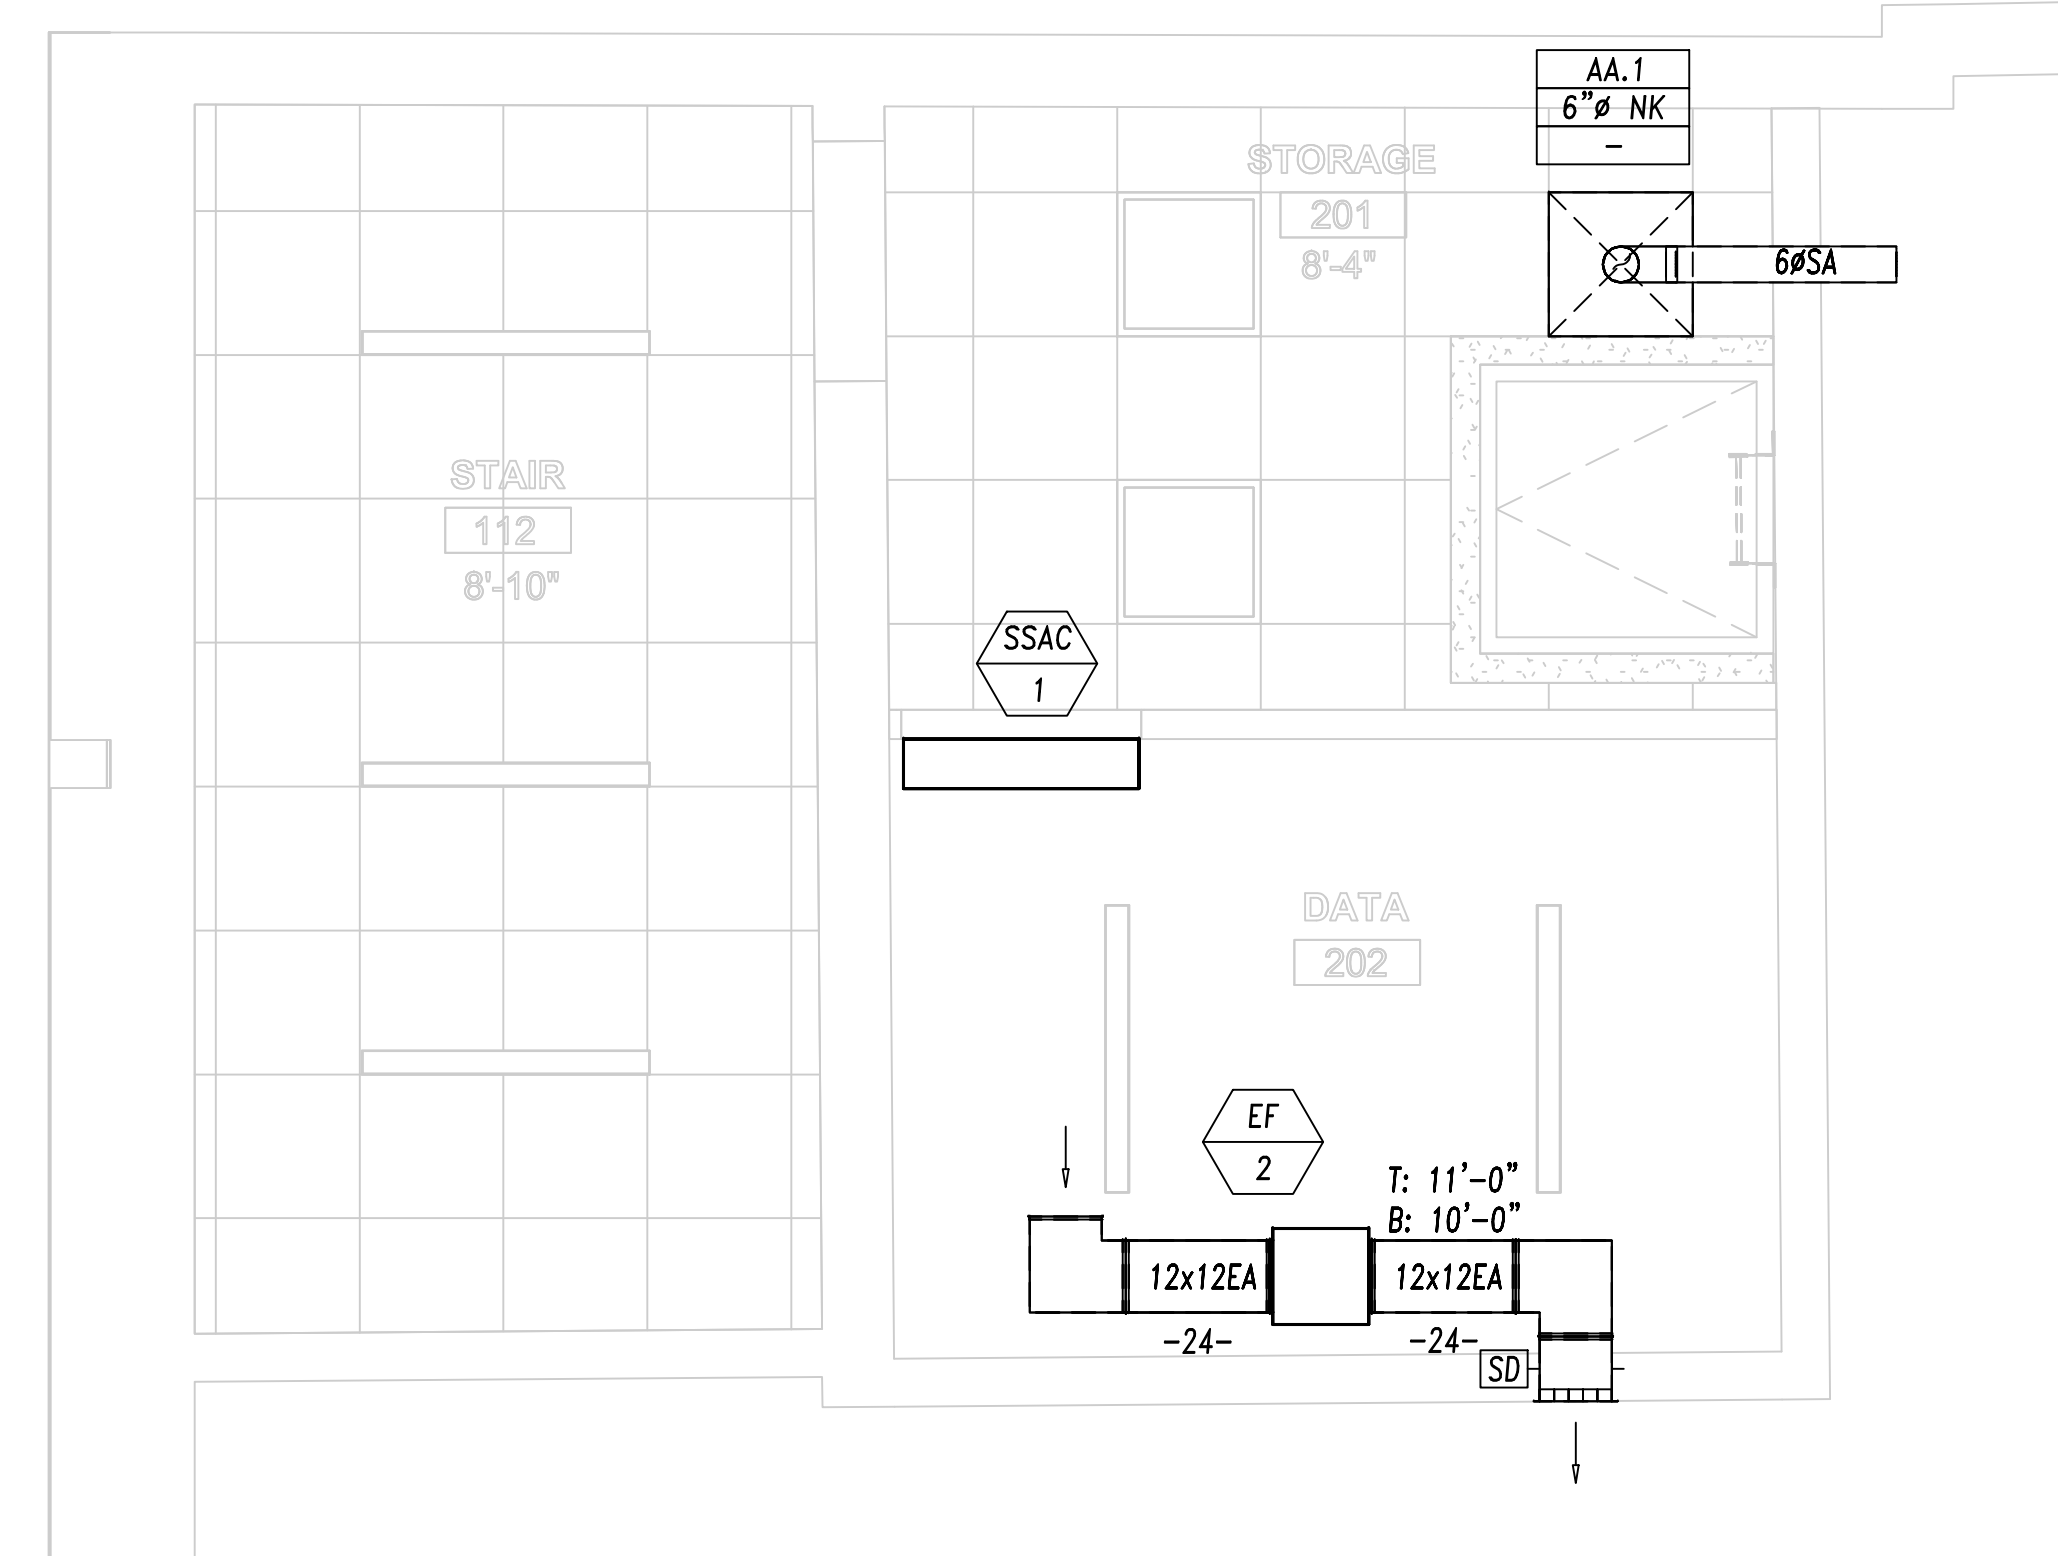

2 MEZZANINE HVAC PLAN
SCALE: 1/4" = 1'-0"

DUCT MATERIAL KEY					
SYSTEM	DESCRIPTION	DUCT MATERIAL	WALL THICKNESS	PRESSURE CLASS	SMACNA SEAL
SA	SUPPLY AIR	GALVANIZED STEEL	SINGLE	2"	B
EA	EXHAUST AIR	GALVANIZED STEEL	SINGLE	2"	B
OA	OUTSIDE AIR	GALVANIZED STEEL	SINGLE	2"	B

1	ADDED VAV-8	SS	7/31/26
1	BULLETIN 1 CHANGES	SS	8/13/26
REV:	DESCRIPTION:	BY:	DATE:
STATUS: CONSTRUCTION ISSUE			


Polaris Drafting LLC
PO Box 1033
Abington, PA 19001
Phone: 215-326-9404

CLIENT:

SITE:


TITLE:	HVAC NEW WORK First Floor		
SCALE: AT 1/4" = 1'-0"	DATE:	DRAWN: SS	CHECKED: SS
PROJECT NO:	DRAWING NO:	REVISION:	
-	SM-101	1	



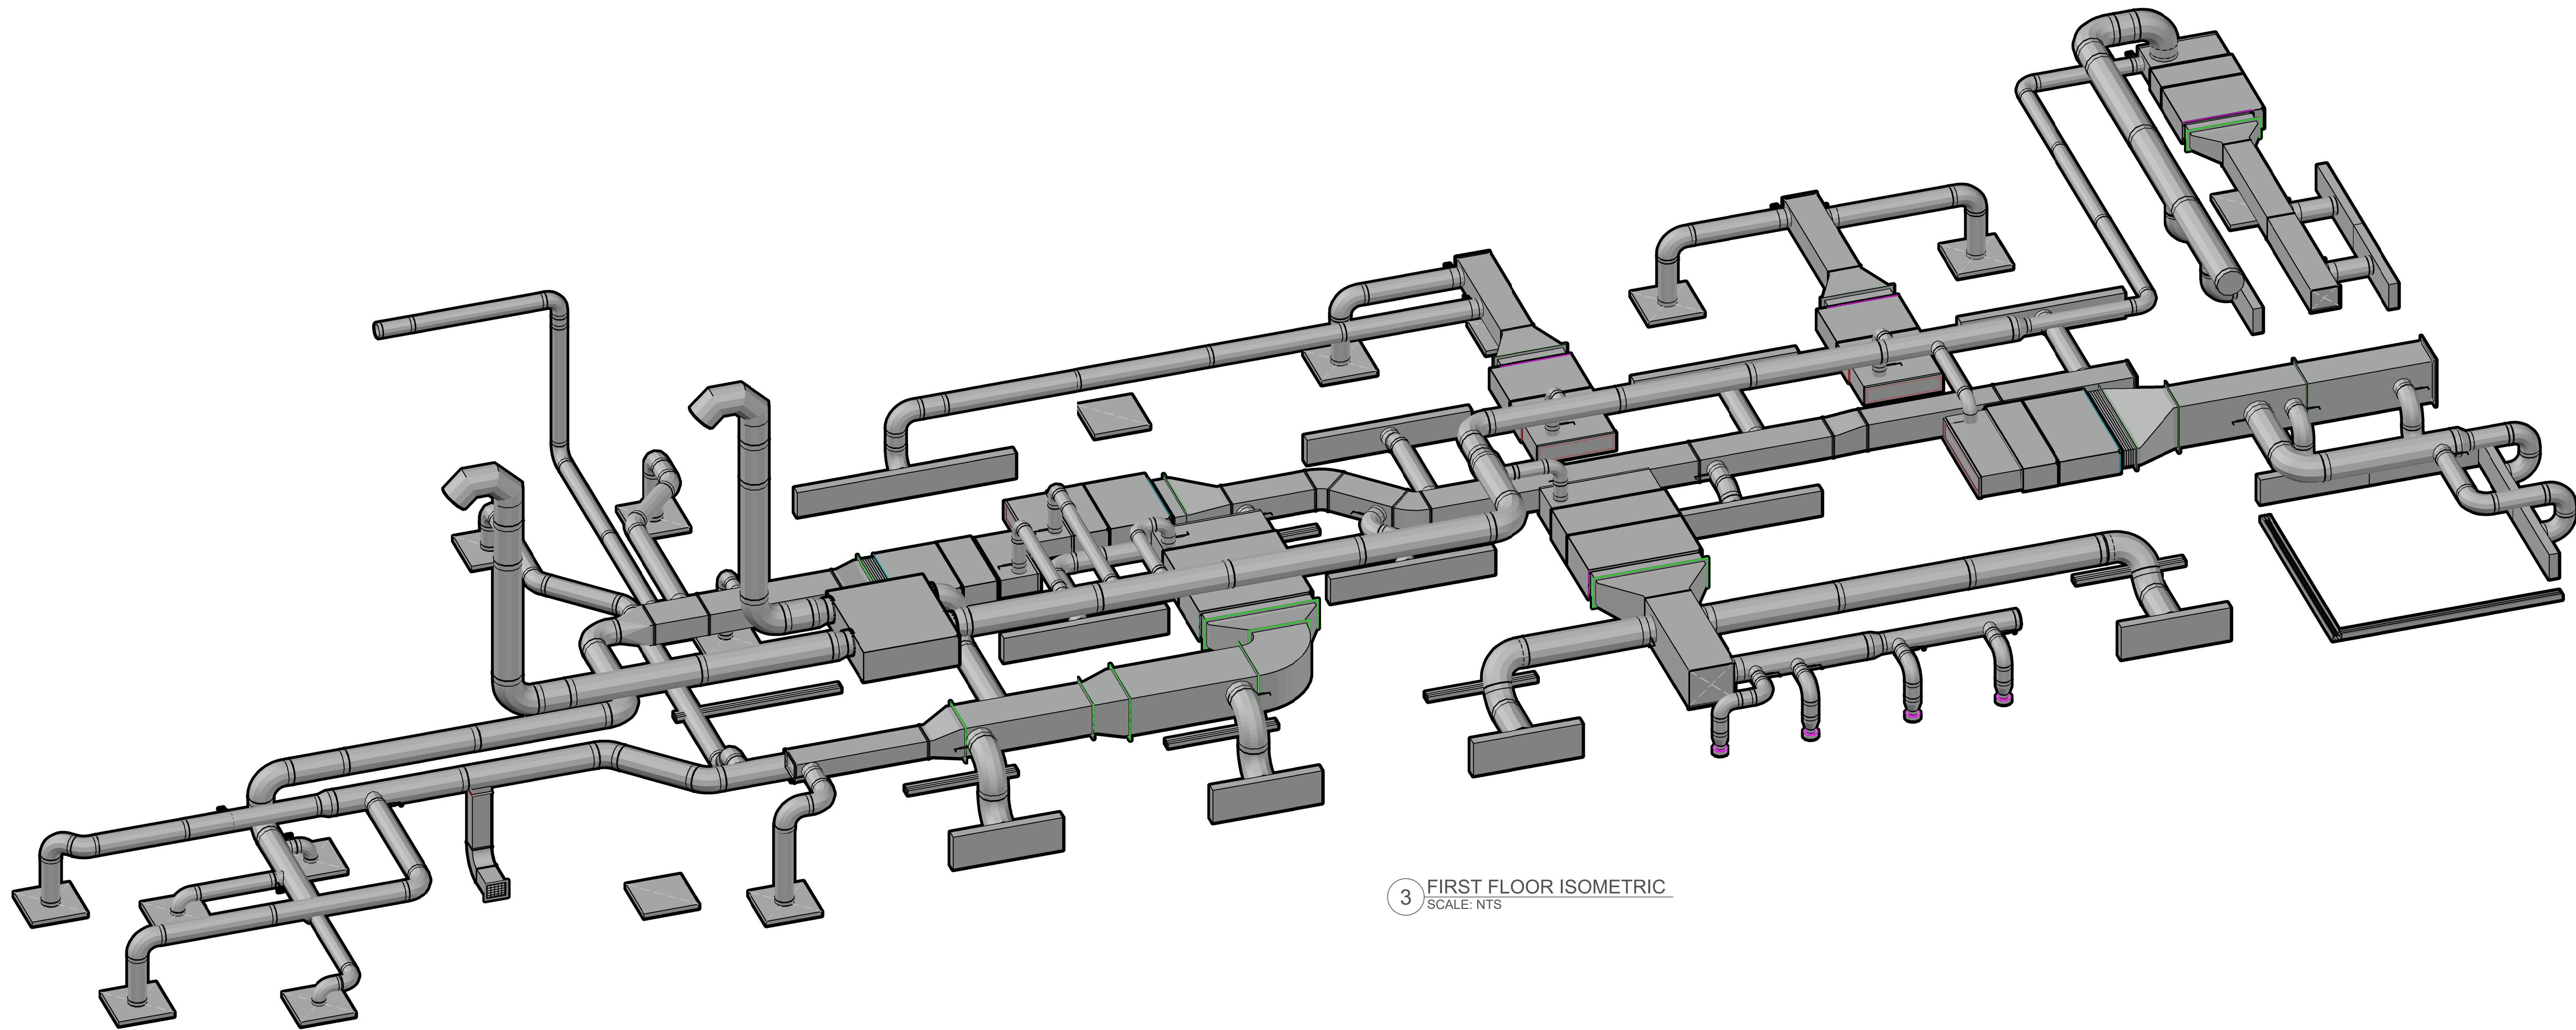

3 FIRST FLOOR ISOMETRIC
SCALE: NTS

REV:	DESCRIPTION:	BY:	DATE:
1	ADDED VAV-8	SS	7/31/26
1	BULLETIN 1 CHANGES	SS	8/13/26
STATUS: CONSTRUCTION ISSUE			

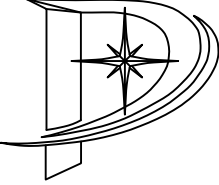 **Polaris Drafting LLC**
PO Box 1033
Abington, PA 19001
Phone: 215-326-9404

CLIENT:

SITE:

TITLE: HVAC NEW WORK First Floor			
SCALE: AT AT:	DATE:	DRAWN:	CHECKED:
AS SHOWN		SS	SS
PROJECT NO:	DRAWING NO:	REVISION:	
-	SM-102	1	

