



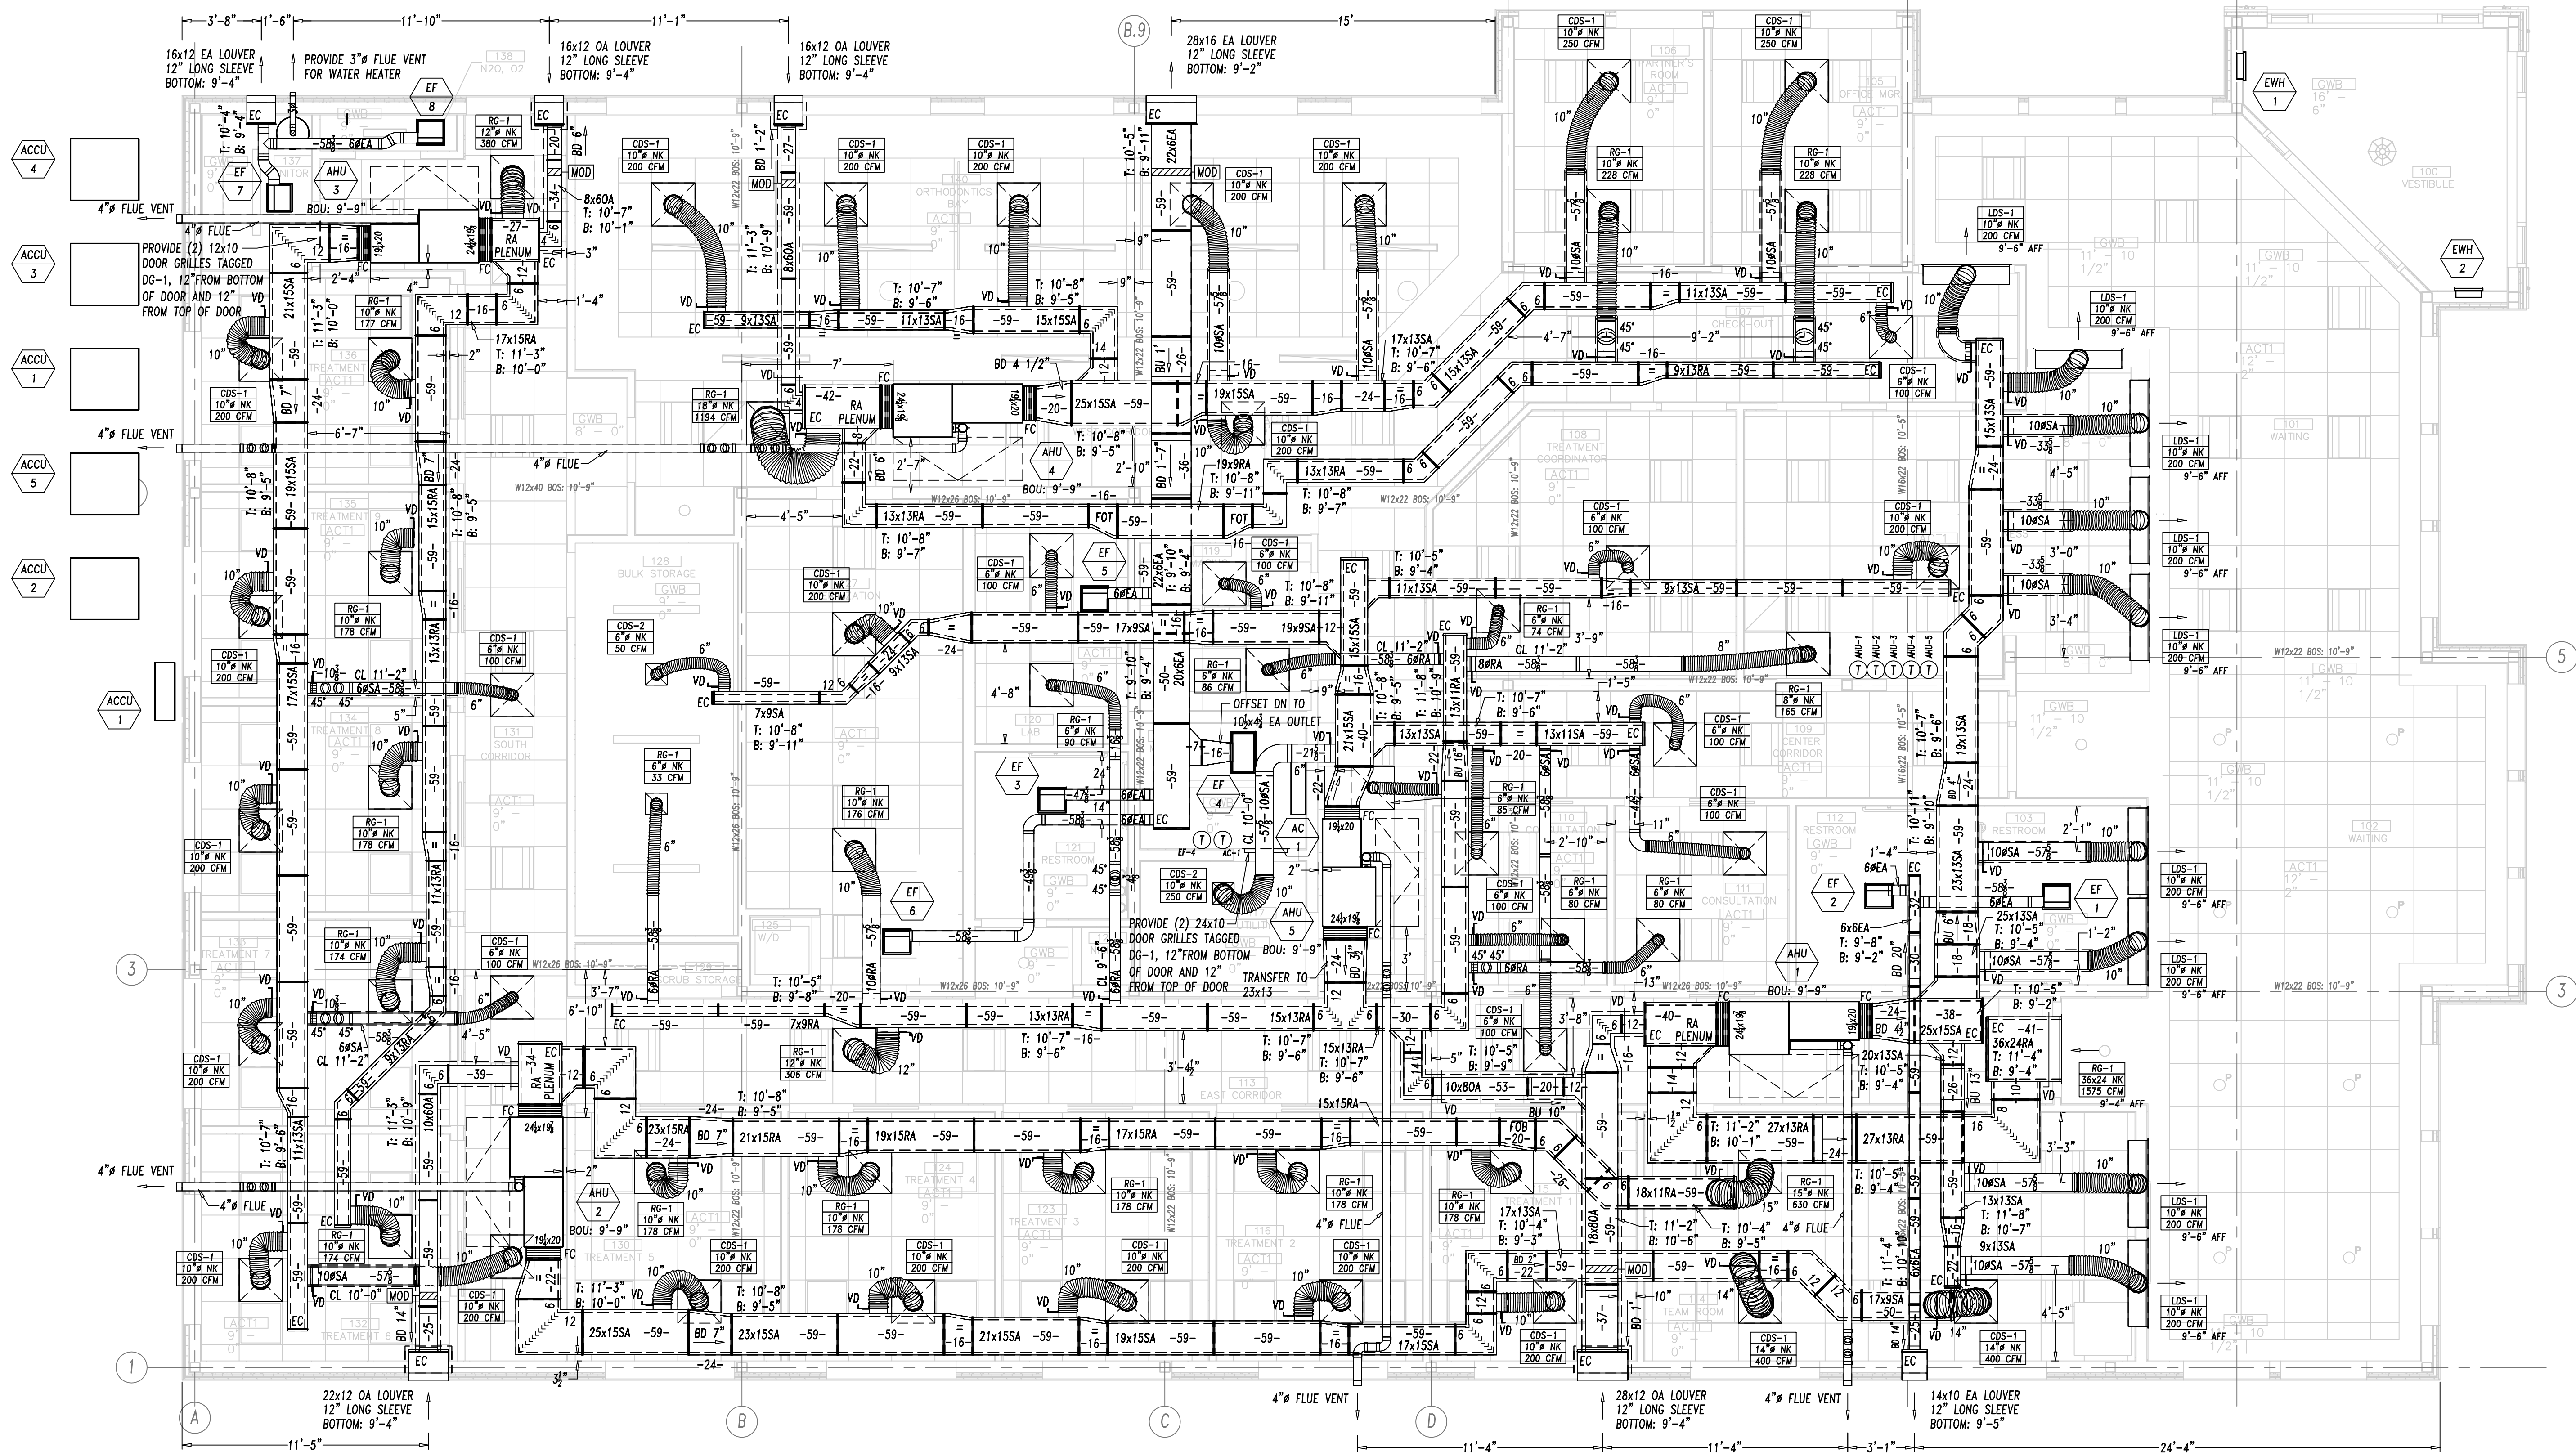

1 FIRST FLOOR HVAC PLAN
SCALE: 1/4" = 1'-0"

INSULATION SCHEDULE					
SYSTEM	DESCRIPTION	SQUARE/ROUND	INSULATION TYPE	THICKNESS	R-VALUE
SA	SUPPLY AIR	SQUARE	LINER	1.5"	6
SA	SUPPLY AIR	ROUND	WRAP	1.5"	6
RA	RETURN AIR	SQUARE	LINER	1.5"	6
RA	RETURN AIR	ROUND	WRAP	1.5"	6
EA	EXHAUST AIR	SQUARE & ROUND	NONE	-	-
OA	OUTSIDE AIR	SQUARE & ROUND	WRAP	2"	2"

2 FIRST FLOOR ISOMETRIC
SCALE: NTS

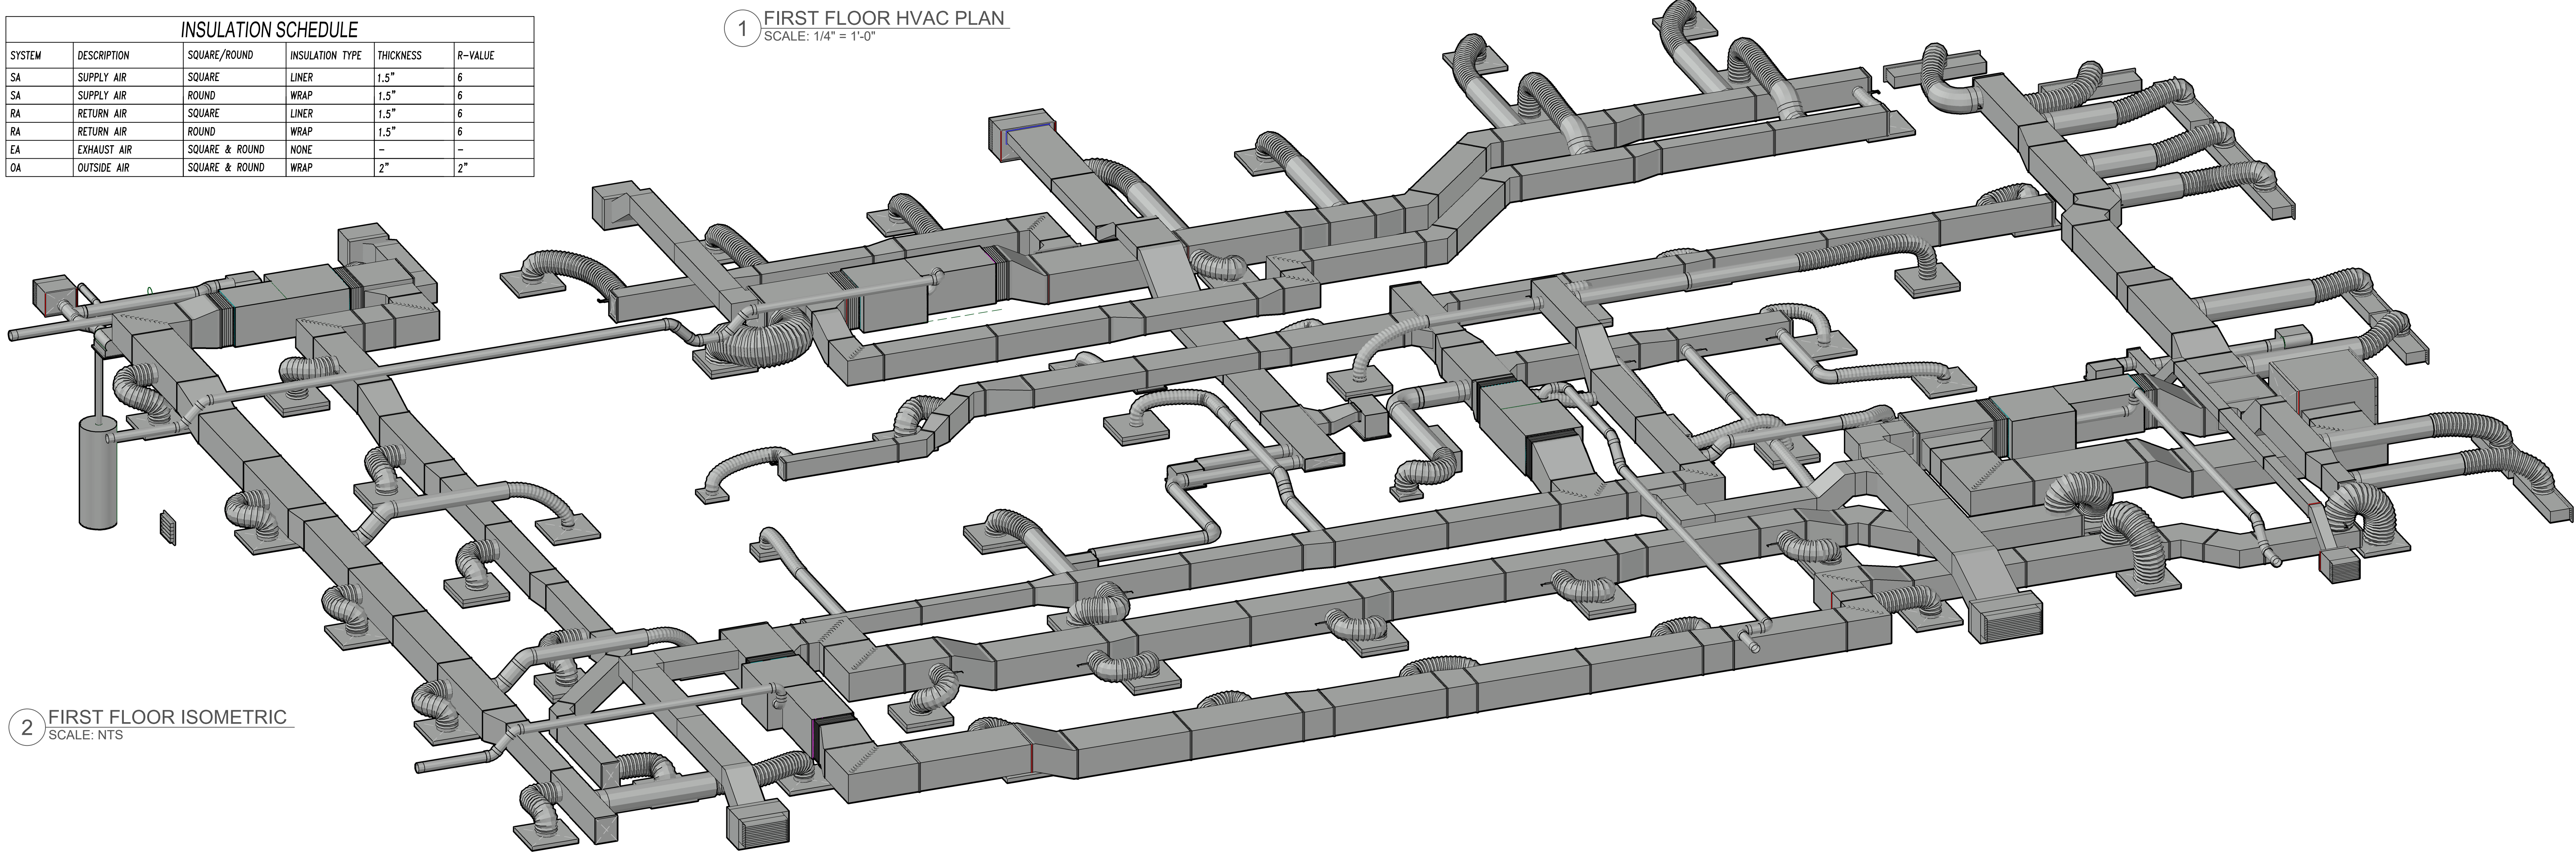

REV:	DESCRIPTION:	BY:	DATE:
STATUS:	CONSTRUCTION ISSUE		

Polaris Drafting LLC
PO Box 1033
Abington, PA 19001
Phone: 215-326-9404

CLIENT:

SITE:

TITLE:
HVAC
NEW WORK
First Floor

SCALE: AT 1/4"	DATE:	DRAWN: SS	CHECKED: SS
PROJECT NO:	DRAWING NO: SM-101	REVISION:	-